

ALL COPY RIGHTS ARE THE SOLE PROPERTY OF HOMESTEAD DESIGNS

Homestead Designs

214-215-1013
 Plano, TEXAS
 e-mail: homestead.designs@verizon.net




REVISION DATE: 05-18-2019 BLP
 PROJECT: KAMINSKI TOWNHOME
 ADDRESS: 2112-2116 SHEA ROAD DALLAS, TX
 PLAN NUMBER: TOWN HOME 1242

DESIGNED AND DRAWN BY: HOMESTEAD DESIGNS
 B.L. PHILLIPS
 FOUNDER-DESIGNER
 214-215-1013
 SCALE: 1/8"=1'-0" (11x17) SHEET
 1/8"=1'-0" (11x17) SHEET

PAGE # 1


CABINET DETAIL IS FOR ILLUSTRATION ONLY. ACTUAL LAYOUT TO BE PROVIDED BY CABINET INSTALLATION COMPANY.

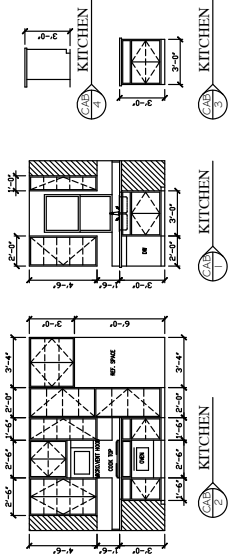

SO. FT. 443
 FIRST FLOOR 709
 SECOND FLOOR 1242
 TOTAL A.C. 406
 PARKING AREA 1688
 TOTAL 2244.5
 SLAB 849
 WIDTH 38'-0"


DOOR SCHEDULE	
1	6'-0" x 8'-0" SW
2	6'-0" x 8'-0" SW
3	6'-0" x 8'-0" SW
100	6'-0" x 8'-0" SW

STREET SIDE END UNIT RIGHT

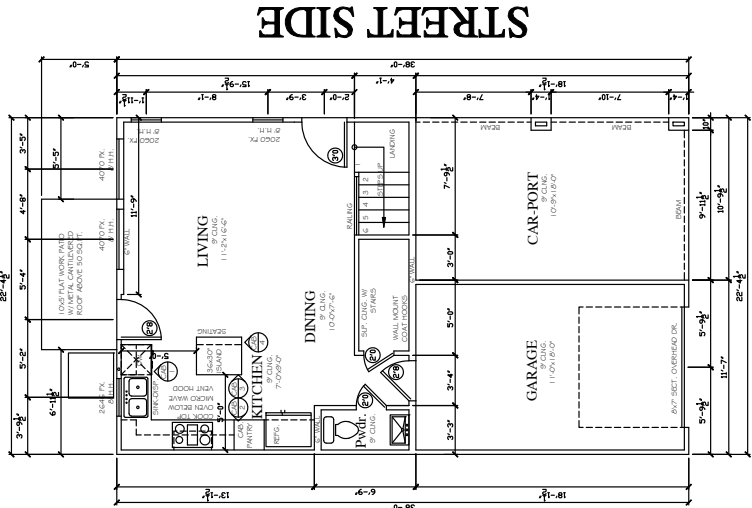

FIRST FLOOR PLAN

ELECTRICAL LEGEND		
HOSE BIBB	CEILING LIGHT	CEILING DUPLEX
SWITCH	RECESSED CEILING LIGHT	FLOOR DUPLEX
THREE-WAY SWITCH	WALL HUNG LIGHT	PHONE OUTLET
FOUR-WAY SWITCH	WALL HUNG FAN	TV OUTLET
PRECEDENT	RECESSED ENDHALL LIGHT	GAS OUTLET
COUNTERTOP DUPLEX	VENT	CARBON MONOXIDE DETECTOR
SPLIT WIRE DUPLEX	VENT AND LIGHT	SMOKE DETECTOR
QUADUPLEX	HEAT AND LIGHT	JUNCTION
	HEAT AND VENT	REAR PANEL
	HEAT, VENT AND LIGHT	LANCASHIRE LIGHT
		FLOORLIGHT

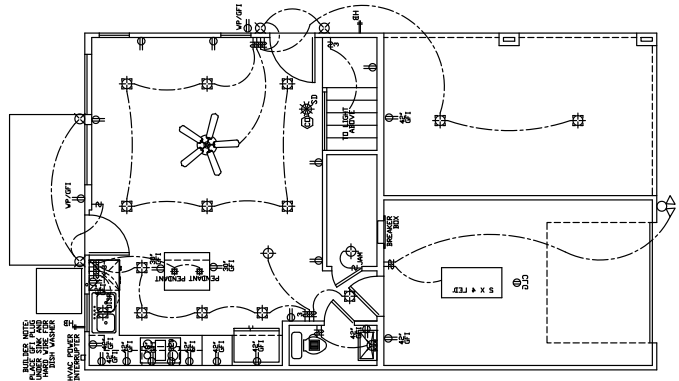

1ST FLOOR ELECTRICAL PLAN