




REVISION DATE	05-18-2019 BLP
PROJECT	KAMINSKI TOWNHOME
ADDRESS:	2112-2116 SHEA ROAD DALLAS, TX.
PLAN NUMBER	TOWN HOME 1242
DESIGNED AND DRAWN BY:	HOMESTEAD DESIGNS
DESIGNER:	B.L. PHILLIPS
FOUNDER:	214-215-1013
SCALE:	1/8"=1'-0" (AS SHOWN)
PAGE #	2

CABINET DETAIL IS FOR ILLUSTRATION ONLY. ACTUAL LAYOUT TO BE PROVIDED BY CABINET INSTALLATION COMPANY.

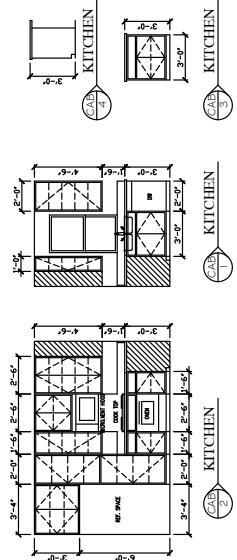


SO. FT.	443
FIRST FLOOR	799
SECOND FLOOR	1242
TOTAL A.C.	406
PARKING AREA	1688
TOTAL SLAB	22'-4.5"
WIDTH	38'-0"

DOOR SCHEDULE	
NO.	DESCRIPTION
1	6'-0" X 8'-0" SW
2	6'-0" X 8'-0" SH
3	6'-0" X 8'-0" SL
4	6'-0" X 8'-0" ST
5	6'-0" X 8'-0" SW
6	6'-0" X 8'-0" SH
7	6'-0" X 8'-0" SL
8	6'-0" X 8'-0" ST
9	6'-0" X 8'-0" SW
10	6'-0" X 8'-0" SH
11	6'-0" X 8'-0" SL
12	6'-0" X 8'-0" ST

WINDOW SCHEDULE	
NO.	DESCRIPTION
1	6'-0" X 8'-0" SW
2	6'-0" X 8'-0" SH
3	6'-0" X 8'-0" SL
4	6'-0" X 8'-0" ST
5	6'-0" X 8'-0" SW
6	6'-0" X 8'-0" SH
7	6'-0" X 8'-0" SL
8	6'-0" X 8'-0" ST
9	6'-0" X 8'-0" SW
10	6'-0" X 8'-0" SH
11	6'-0" X 8'-0" SL
12	6'-0" X 8'-0" ST


STREET SIDE END UNIT LEFT

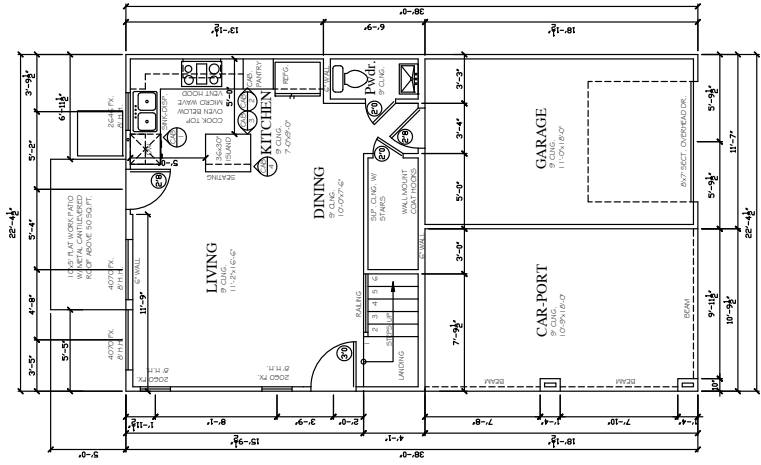

STREET SIDE

FIRST FLOOR PLAN

ELECTRICAL LEGEND	
	15 AMP BRK
	20 AMP BRK
	30 AMP BRK
	40 AMP BRK
	50 AMP BRK
	60 AMP BRK
	70 AMP BRK
	80 AMP BRK
	90 AMP BRK
	100 AMP BRK
	125 AMP BRK
	150 AMP BRK
	200 AMP BRK
	250 AMP BRK
	300 AMP BRK
	350 AMP BRK
	400 AMP BRK
	450 AMP BRK
	500 AMP BRK
	600 AMP BRK
	700 AMP BRK
	800 AMP BRK
	900 AMP BRK
	1000 AMP BRK
	1500 AMP BRK
	2000 AMP BRK
	2500 AMP BRK
	3000 AMP BRK
	3500 AMP BRK
	4000 AMP BRK
	4500 AMP BRK
	5000 AMP BRK
	5500 AMP BRK
	6000 AMP BRK
	6500 AMP BRK
	7000 AMP BRK
	7500 AMP BRK
	8000 AMP BRK
	8500 AMP BRK
	9000 AMP BRK
	9500 AMP BRK
	10000 AMP BRK
	15000 AMP BRK
	20000 AMP BRK
	25000 AMP BRK
	30000 AMP BRK
	35000 AMP BRK
	40000 AMP BRK
	45000 AMP BRK
	50000 AMP BRK
	55000 AMP BRK
	60000 AMP BRK
	65000 AMP BRK
	70000 AMP BRK
	75000 AMP BRK
	80000 AMP BRK
	85000 AMP BRK
	90000 AMP BRK
	95000 AMP BRK
	100000 AMP BRK
	150000 AMP BRK
	200000 AMP BRK
	250000 AMP BRK
	300000 AMP BRK
	350000 AMP BRK
	400000 AMP BRK
	450000 AMP BRK
	500000 AMP BRK
	550000 AMP BRK
	600000 AMP BRK
	650000 AMP BRK
	700000 AMP BRK
	750000 AMP BRK
	800000 AMP BRK
	850000 AMP BRK
	900000 AMP BRK
	950000 AMP BRK
	1000000 AMP BRK
	1500000 AMP BRK
	2000000 AMP BRK
	2500000 AMP BRK
	3000000 AMP BRK
	3500000 AMP BRK
	4000000 AMP BRK
	4500000 AMP BRK
	5000000 AMP BRK
	5500000 AMP BRK
	6000000 AMP BRK
	6500000 AMP BRK
	7000000 AMP BRK
	7500000 AMP BRK
	8000000 AMP BRK
	8500000 AMP BRK
	9000000 AMP BRK
	9500000 AMP BRK
	10000000 AMP BRK
	15000000 AMP BRK
	20000000 AMP BRK
	25000000 AMP BRK
	30000000 AMP BRK
	35000000 AMP BRK
	40000000 AMP BRK
	45000000 AMP BRK
	50000000 AMP BRK
	55000000 AMP BRK
	60000000 AMP BRK
	65000000 AMP BRK
	70000000 AMP BRK
	75000000 AMP BRK
	80000000 AMP BRK
	85000000 AMP BRK
	90000000 AMP BRK
	95000000 AMP BRK
	100000000 AMP BRK
	150000000 AMP BRK
	200000000 AMP BRK
	250000000 AMP BRK
	300000000 AMP BRK
	350000000 AMP BRK
	400000000 AMP BRK
	450000000 AMP BRK
	500000000 AMP BRK
	550000000 AMP BRK
	600000000 AMP BRK
	650000000 AMP BRK
	700000000 AMP BRK
	750000000 AMP BRK
	800000000 AMP BRK
	850000000 AMP BRK
	900000000 AMP BRK
	950000000 AMP BRK
	1000000000 AMP BRK

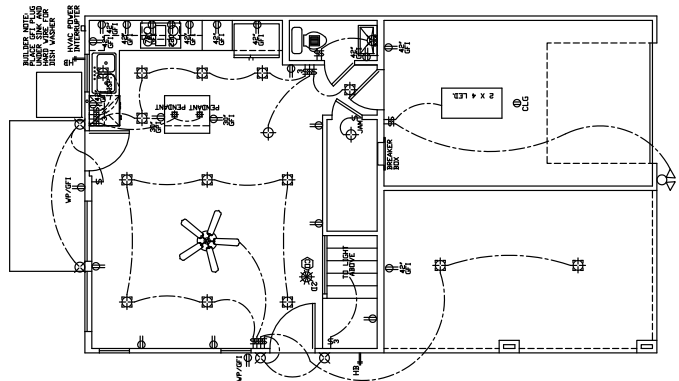

1ST FLOOR ELECTRICAL PLAN